



MATERIALS LEGEND	
S1	STONE VENEER - COLOR BRAND ETC
B1	BRICK VENEER - COLOR BRAND ETC
B2	BRICK VENEER - COLOR BRAND ETC
G1	ALUMINUM STOREFRONT: MANUF- KAWNEER, MODEL- TRIFAB VG 451 (FRONT) TYPE 'B' ASSEMBLY - WEATHER SEAL GLASS TO BE 1" INSULATED GLAZING WITH LOW-E COATING SOLARBAN-72AS BY PPG.
S2	SYNTHETIC STONE - COLOR BRAND ETC
P1	EXTERIOR PAINT - COLOR BRAND ETC
P2	EXTERIOR PAINT - COLOR BRAND ETC


- GENERAL NOTES**
- 1) PROVIDE BLOCKING AS REQUIRED IN RESTROOM WALLS FOR PLUMBING FIXTURES AND ACCESSORIES.
 - 2) ALL DIMENSIONS TO FACE OF STUD, UNO.
 - 3) THE INTEGRITY OF ALL FLASHING, COPING, FLASHING AND COUNTER-FLASHING SHALL BE MAINTAINED.
 - 4) FLASHING, COPING, GUTTERS, DOWNSPOUTS, AND COUNTER-FLASHING SHALL BE PAINTED, P1.
 - 5) G.C. TO PROVIDE IN-WALL BLOCKING AS REQUIRED FOR INSTALLATION OF AWNINGS SHOWN AND AS DIRECTED BY THE AWNING MANUFACTURER.

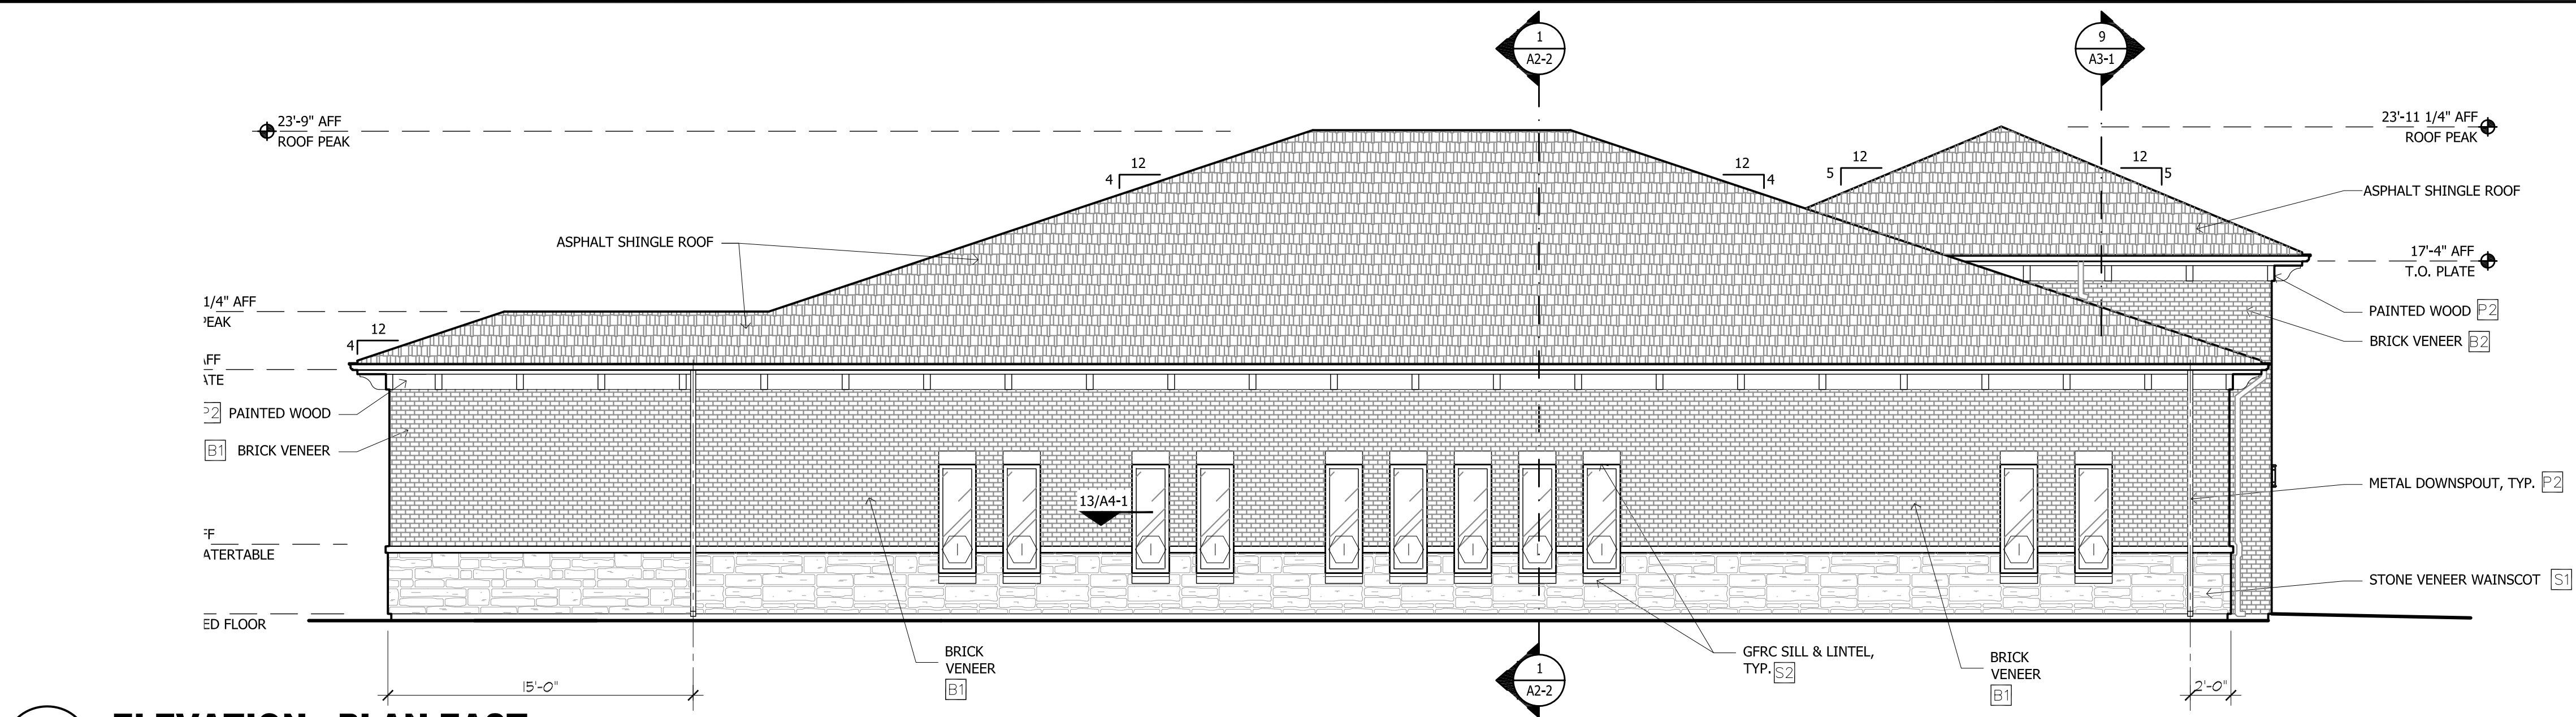


1 ELEVATION - PLAN EAST
SCALE: 3/16" = 1'-0"

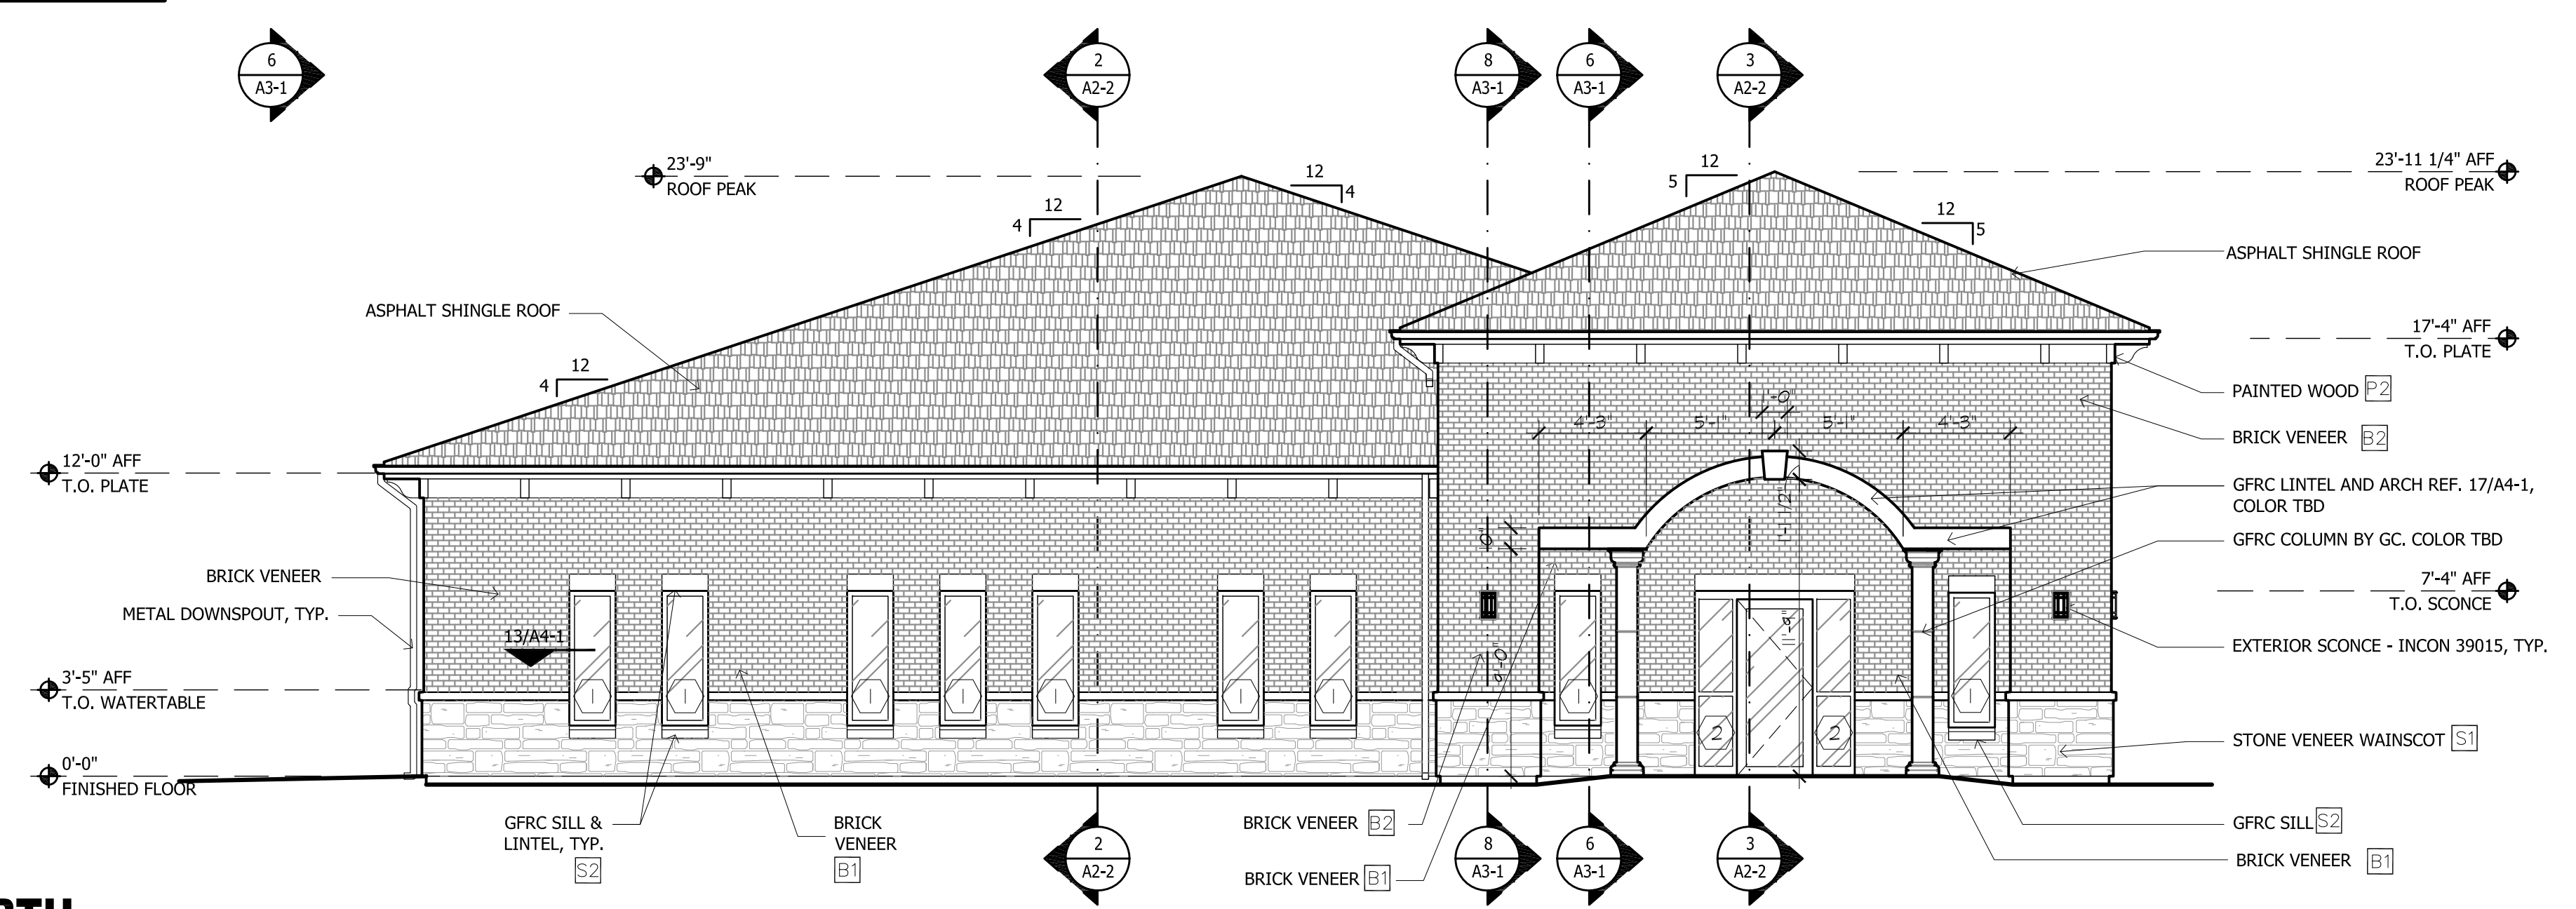

2 ELEVATION - PLAN NORTH
SCALE: 3/16" = 1'-0"

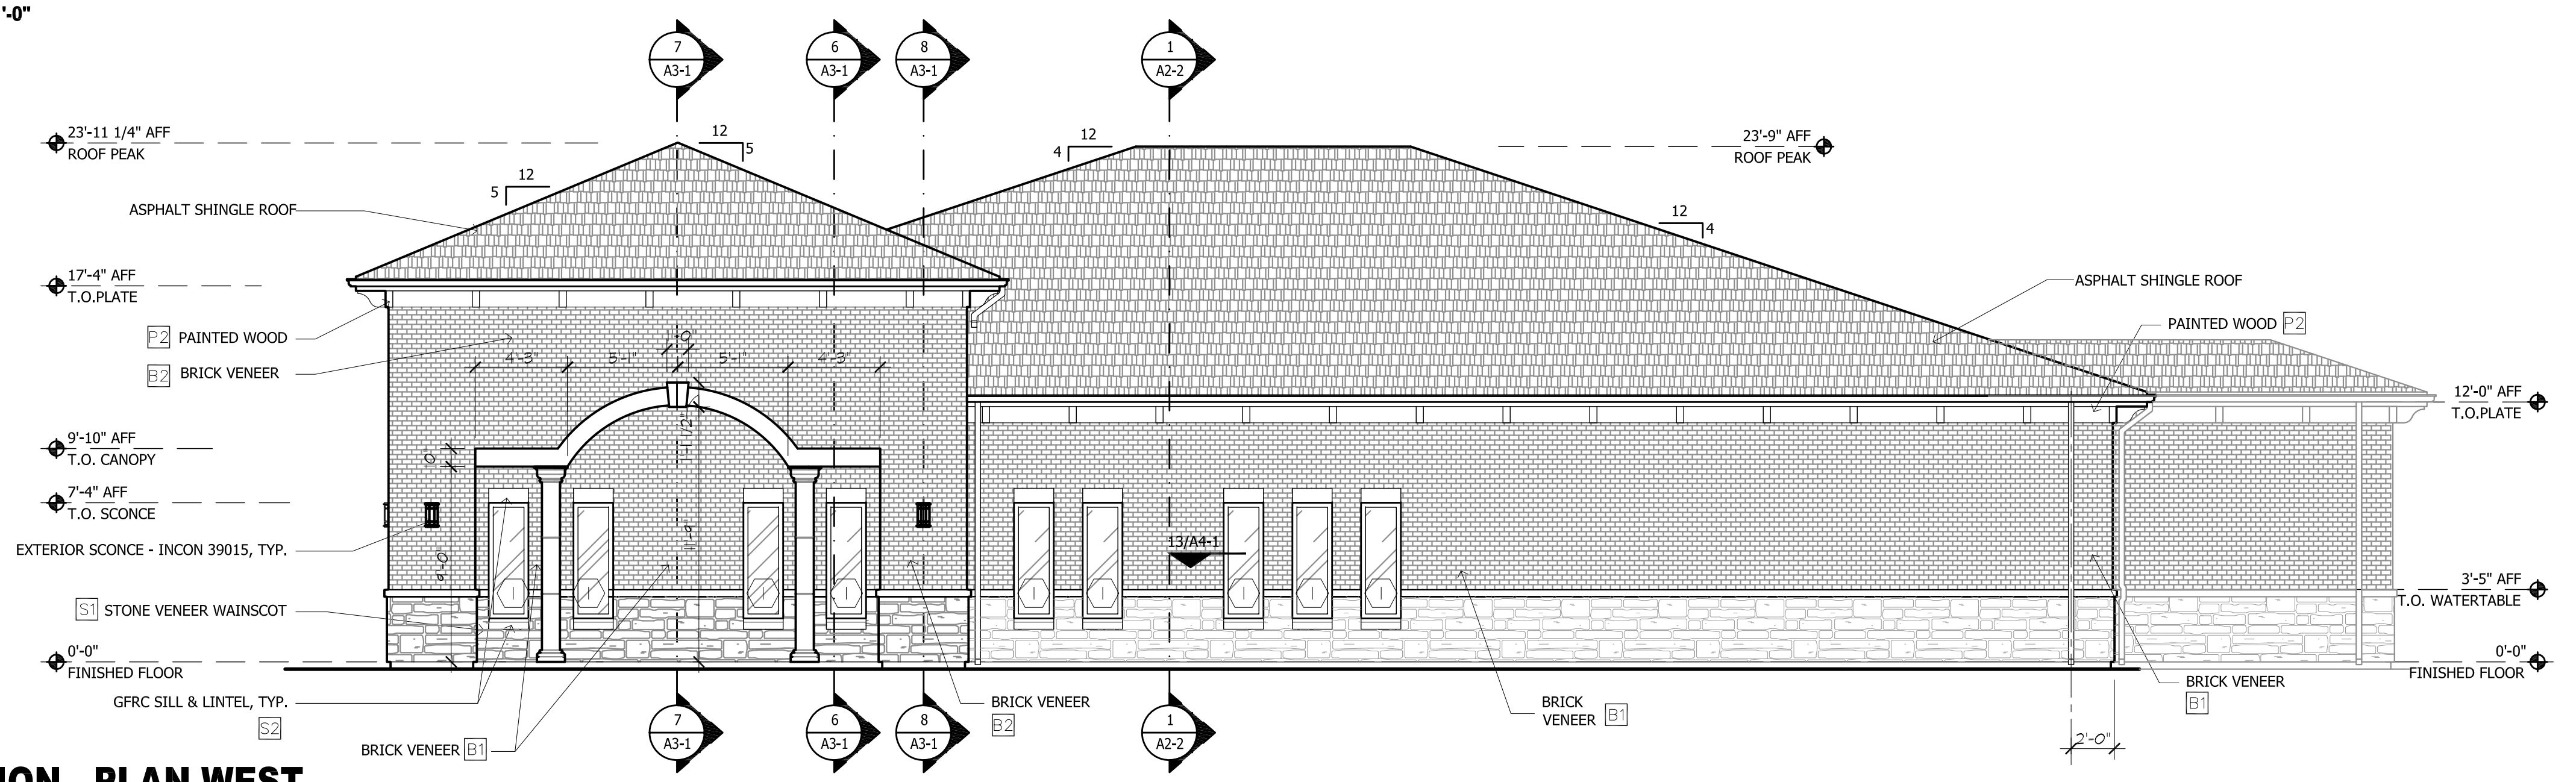

3 ELEVATION - PLAN WEST
SCALE: 3/16" = 1'-0"

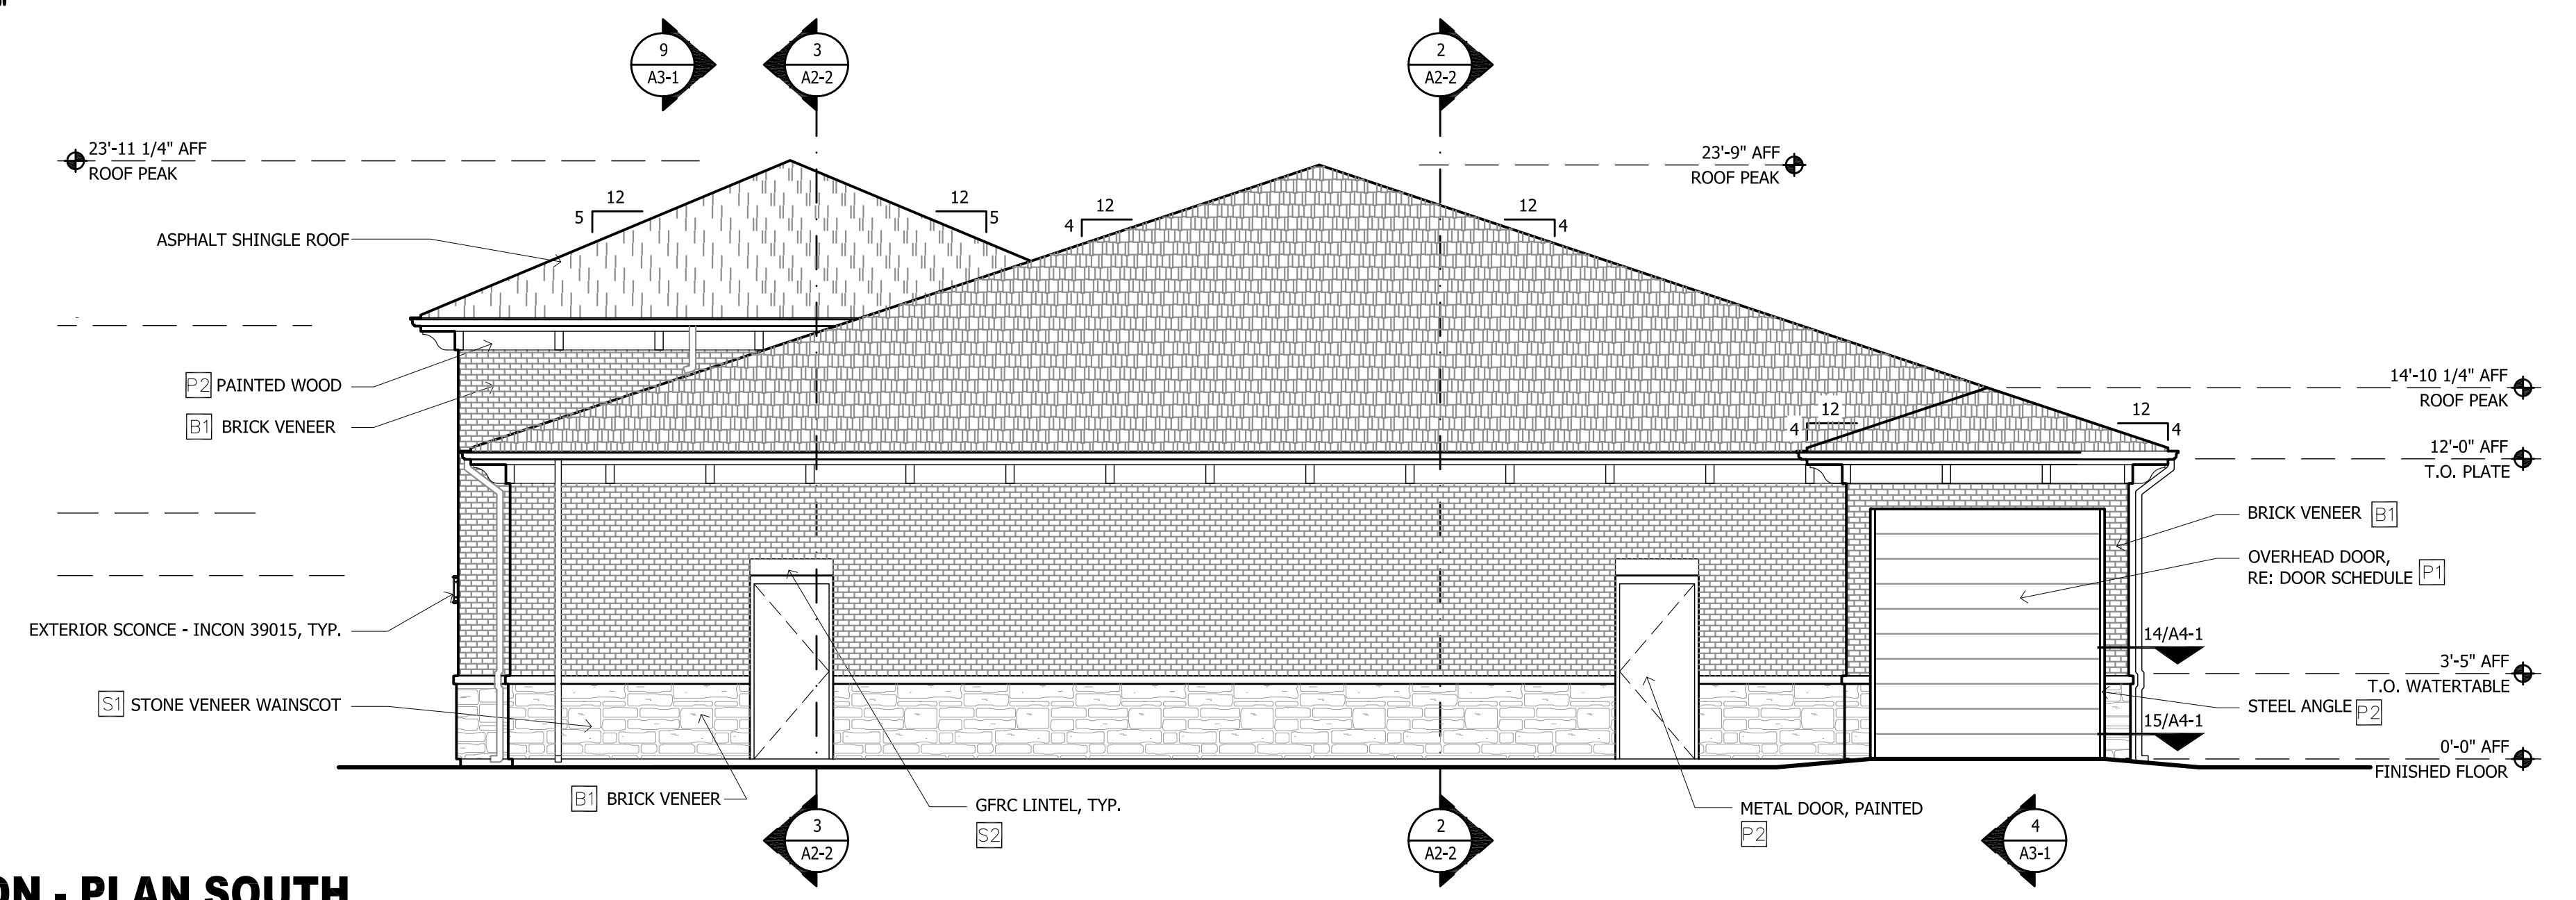

4 ELEVATION - PLAN SOUTH
SCALE: 3/16" = 1'-0"

RECEIVED
By Kathy Wright at 2:49 pm, Apr 08, 2013